


SCHEDULE OF DRAWINGS

DRAWING No.	DESCRIPTION
7900/48/01 - 100	COVER SHEET
GENERAL	
7900/48/01 - 101	LOCALITY PLAN AND SCHEDULE OF DRAWINGS
7900/48/01 - 102	MASTER LAYOUT PLAN
7900/48/01 - 103	BOUNDARY AND WALL LOCATION PLAN
7900/48/01 - 104	PROPOSED FUTURE WORKS
BULK EARTHWORKS	
7900/48/01 - 105	DESIGN SURFACE
7900/48/01 - 106	CUT AND FILL VOLUMES LAYOUT PLAN
7900/48/01 - 107	CUT AND FILL SITE SECTIONS - SHEET 1 OF 4
7900/48/01 - 108	CUT AND FILL SITE SECTIONS - SHEET 2 OF 4
7900/48/01 - 109	CUT AND FILL SITE SECTIONS - SHEET 3 OF 4
7900/48/01 - 110	CUT AND FILL SITE SECTIONS - SHEET 4 OF 4
7900/48/01 - 111	BOREHOLES AND MARINE CLAY CONTOURS LAYOUT PLAN
7900/48/01 - 112	BOREHOLES AND RESIDUAL CLAY CONTOURS LAYOUT PLAN
SHUTE HARBOUR ROAD	
7900/48/01 - 200	ROAD LAYOUT PLAN
7900/48/01 - 201	TYPICAL ROAD CROSS SECTIONS
7900/48/01 - 202	SHUTE HARBOUR ROAD LONGITUDINAL SECTION
7900/48/01 - 203	SHUTE HARBOUR ROAD PROPOSED TWO LANE CROSS SECTIONS - SHEET 1 OF 5
7900/48/01 - 204	SHUTE HARBOUR ROAD PROPOSED TWO LANE CROSS SECTIONS - SHEET 2 OF 5
7900/48/01 - 205	SHUTE HARBOUR ROAD PROPOSED TWO LANE CROSS SECTIONS - SHEET 3 OF 5
7900/48/01 - 206	SHUTE HARBOUR ROAD PROPOSED TWO LANE CROSS SECTIONS - SHEET 4 OF 5
7900/48/01 - 207	SHUTE HARBOUR ROAD PROPOSED TWO LANE CROSS SECTIONS - SHEET 5 OF 5
7900/48/01 - 208	DRAINAGE LAYOUT PLAN
7900/48/01 - 209	DRAINAGE CULVERT SECTION - SHEET 1 OF 3
7900/48/01 - 210	DRAINAGE CULVERT SECTION - SHEET 2 OF 3
7900/48/01 - 211	DRAINAGE CULVERT SECTION - SHEET 3 OF 3
MARINA	
7900/48/01 - 300	REVTMENT WALL AND BREAKWATER LAYOUT PLAN
7900/48/01 - 301	WALL 1 - SHEETPILE REVTMENT LONGITUDINAL SECTION - SHEET 1 OF 2
7900/48/01 - 302	WALL 1 - SHEETPILE REVTMENT LONGITUDINAL SECTION - SHEET 2 OF 2
7900/48/01 - 303	WALL 6 - TEMPORARY SHEETPILE LONGITUDINAL SECTION
7900/48/01 - 304	WALL 3 - BUND WALL LONGITUDINAL SECTION
7900/48/01 - 305	WALLS 4 AND 5 - BREAKWATER LONGITUDINAL SECTION - SHEET 1 OF 2
7900/48/01 - 306	WALLS 4 AND 5 - BREAKWATER LONGITUDINAL SECTION - SHEET 2 OF 2
7900/48/01 - 307	REVTMENT WALL DETAILS - WALL 1
7900/48/01 - 308	WALL DETAILS - WALLS 3 AND 6
7900/48/01 - 309	TYPICAL ROAD CROSS SECTIONS
7900/48/01 - 310	TYPICAL CROSS SECTIONS
7900/48/01 - 311	DRAINAGE LAYOUT PLAN
7900/48/01 - 312	DREDGE SPOIL TREATMENT AREA SECTION
7900/48/01 - 350	WALLS 4 AND 5 BREAKWATER - TYPICAL ELEVATION
7900/48/01 - 351	WALLS 4 AND 5 BREAKWATER - OPTION USING CONCRETE BLOCKS - TYPICAL ELEVATION
CONSTRUCTION	
7900/48/01 - 400	CONSTRUCTION MASTER PLAN
7900/48/01 - 401	CONSTRUCTION PHASE 1
7900/48/01 - 402	CONSTRUCTION PHASE 2
7900/48/01 - 403	CONSTRUCTION PHASE 3
7900/48/01 - 404	CONSTRUCTION PHASE 4
7900/48/01 - 405	CONSTRUCTION PHASE 5
7900/48/01 - 406	SEDIMENT AND EROSION CONTROL PLAN - STANDARD NOTES AND DETAILS
7900/48/01 - 407	SEDIMENT AND EROSION CONTROL PLAN - PHASE 1
7900/48/01 - 408	SEDIMENT AND EROSION CONTROL PLAN - PHASE 2
7900/48/01 - 409	SEDIMENT AND EROSION CONTROL PLAN - PHASE 3
7900/48/01 - 410	SEDIMENT AND EROSION CONTROL PLAN - PHASE 4
7900/48/01 - 411	SEDIMENT AND EROSION CONTROL PLAN - PHASE 5

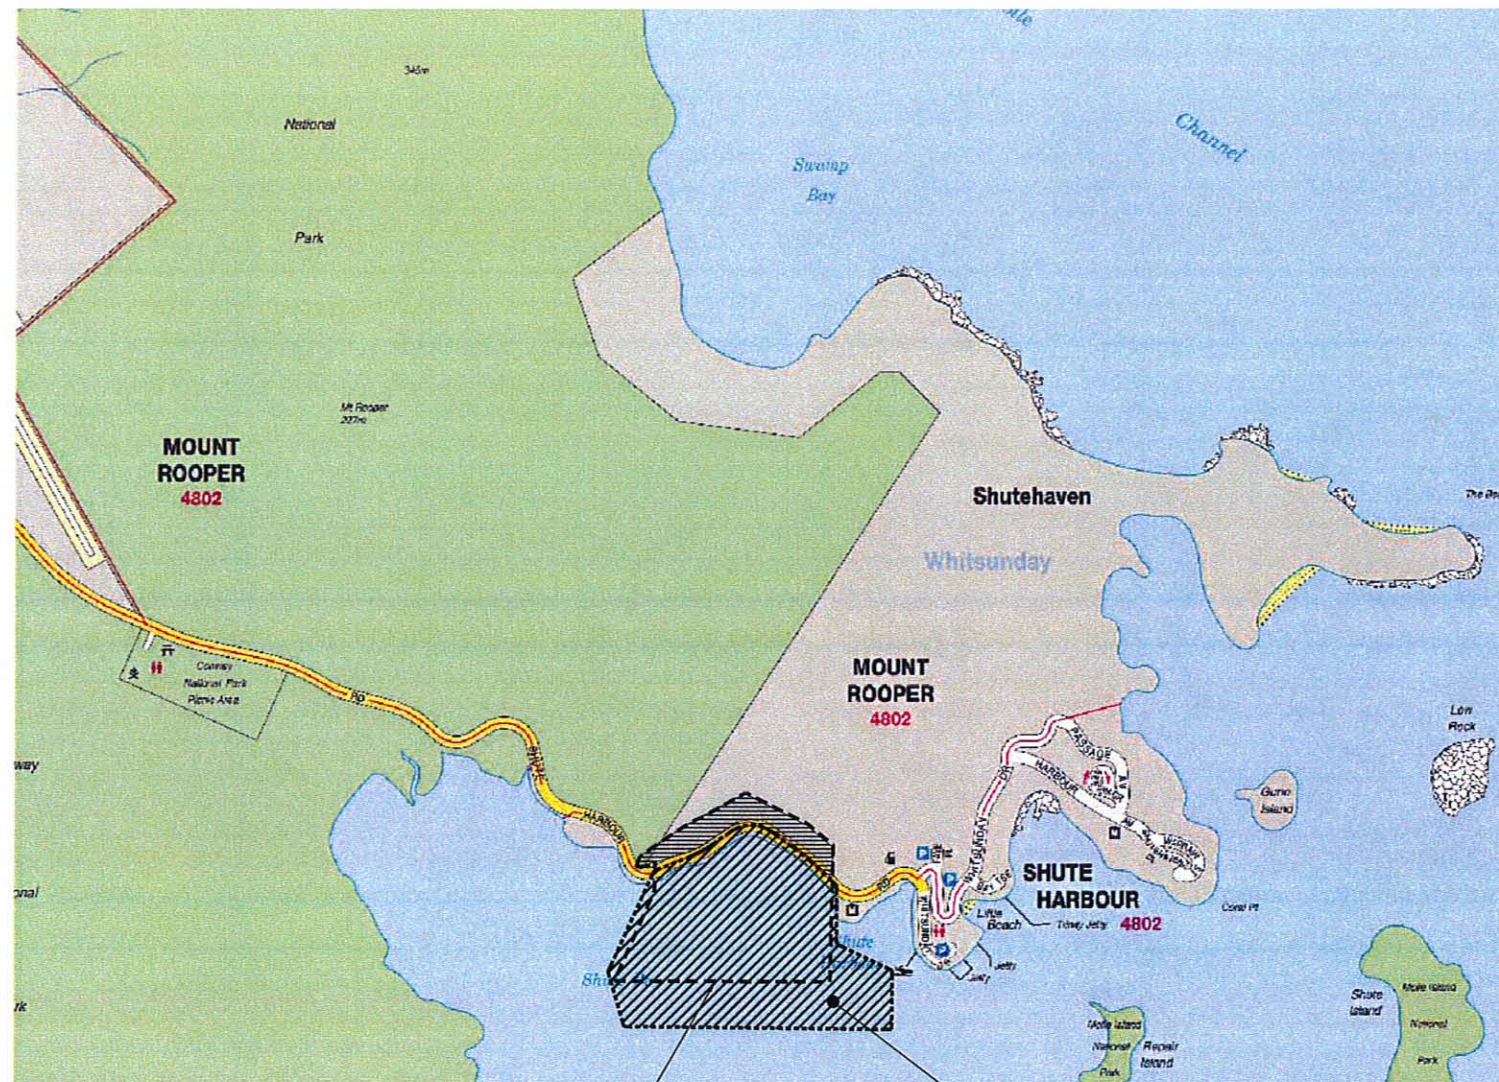

EXISTING LEASE BOUNDARY

SITE LOCATION

LOCALITY PLAN
N.T.S.

DATE PLOTTED: 08 October, 2008 - 3:44pm

© Cardno (Qld) Pty Ltd All Rights Reserved 2005.
Copyright in the whole and every part of this drawing belongs to Cardno (Qld) Pty Ltd and may not be used, sold, transferred, copied or reproduced in whole or in part in any manner or form or on any media, to any person other than by agreement with Cardno (Qld) Pty Ltd.

This document is produced by Cardno (Qld) Pty Ltd solely for the benefit of and use by the client in accordance with the terms of the retainer. Cardno (Qld) Pty Ltd does not and shall not assume any responsibility or liability whatsoever to any third party arising out of any use or reliance by third party on the content of this document.

DESIGNED: *ED*
DRAWN: *SP*
CHECKED: *SC*

RECOMMENDED: PROJ. MAN. *[Signature]* APPROVED: PROJ. DIR. *[Signature]*

A1 DATUM: A.H.D. RPEQ: 1470

CAD FILE: L:\1900-48\01\Acad\79004801-101.dwg
XREF: KR-A1-80-SHT

Cardno
Level 1, 5 Gardner Close, Milton 4064
P.O. Box 304, Toowoomba 4006
Email: cardno@cardno.com.au
Web: www.cardno.com.au
ACN: 051 074 992

OFFICES: TELEPHONE FAX
Brisbane (07) 3369 9822 (07) 3369 9722
Sydney (02) 9416 8233 (02) 9416 8529
Gold Coast (07) 5539 8333 (07) 5539 4647
Sunshine Coast (07) 5443 2555 (07) 5443 5642
Townsville (07) 4772 1186 (07) 4721 2508
Harvey Bay (07) 4124 5455 (07) 4124 5155
Central Coast (02) 4323 2558 (02) 4324 3251
Melbourne (03) 9818 7755 (03) 9818 7033
Rockhampton (07) 4924 7500 (07) 4928 4375
Toowoomba (07) 4637 8122 (07) 4637 8155

SHUTE HARBOUR MARINA DEVELOPMENT
SHUTE HARBOUR MARINA
GENERAL
LOCALITY PLAN AND SCHEDULE OF DRAWINGS

DATE: 1-08-2008
DRAWING No: **7900/48/01-101**
Rv: **A**