
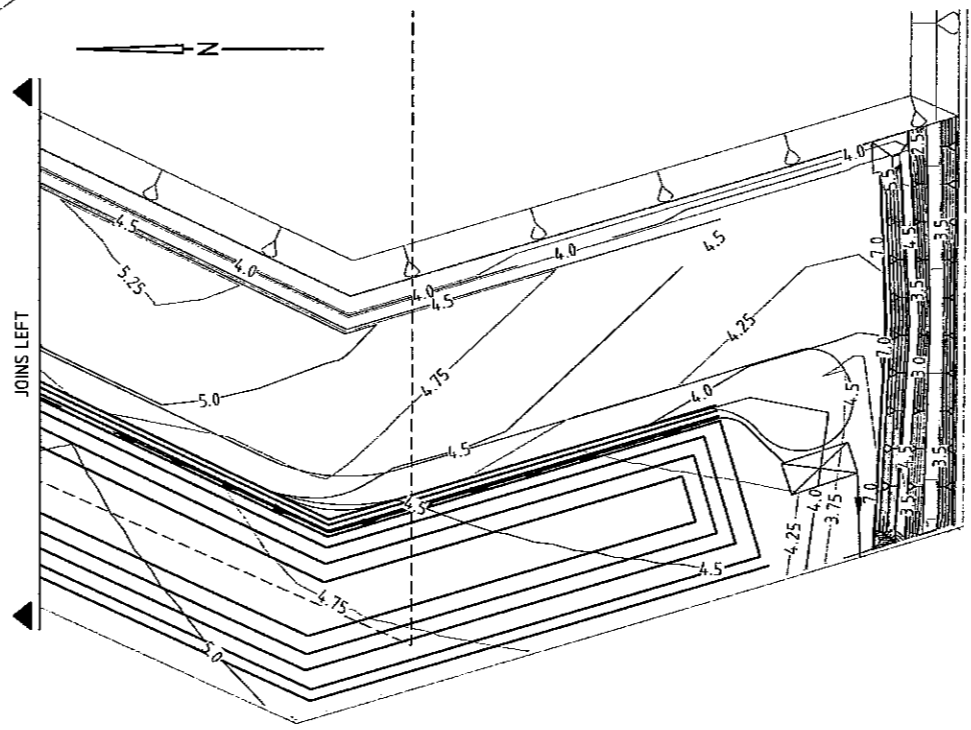
 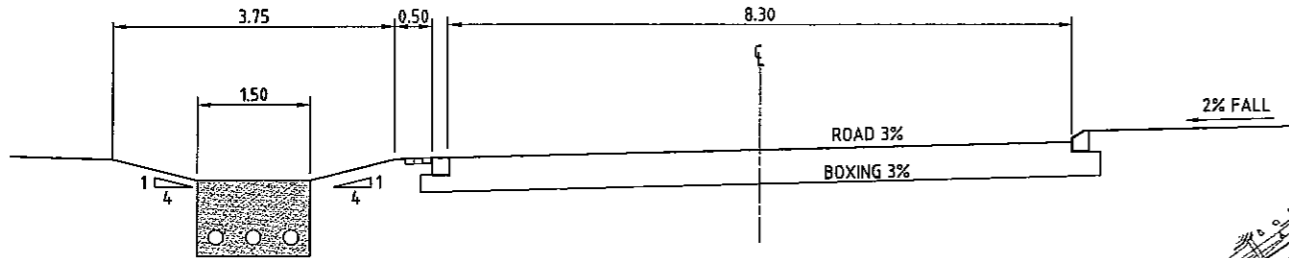


SECTION 1
SCALE 1:50

LAYOUT PLAN
SCALE 1:1000

LEGEND:

- PROPOSED CONTOURS (0.5m)
- DRAINAGE CHANNEL
- TOP OF BANK DRAINAGE
- DRAINAGE SHOULDER
- PROPOSED SWALE DRAINS
- PROPOSED BIO-RETENTION BASINS



DATE PLOTTED: 10/02/08 20:08 - 02/08

© Cardno (Qld) Pty Ltd All Rights Reserved 2006. Copyright in the whole and every part of this drawing belongs to Cardno (Qld) Pty Ltd and may not be used, sold, transferred, copied or reproduced in whole or in part in any manner or form or on any media, to any person other than by agreement with Cardno (Qld) Pty Ltd.		DESIGNED: <i>SK</i>	A1 DATUM: A.H.D.
This document is produced by Cardno (Qld) Pty Ltd solely for the benefit of and use by the client in accordance with the terms of the retainer. Cardno (Qld) Pty Ltd does not and shall not assume any responsibility or liability whatsoever to any third party arising out of any use or reliance by third party on the content of this document.		CHECKED: <i>SK</i>	APPROVED: PROJ. DIR. <i>SK</i>
RECOMMENDED: PROJ. MAN. <i>SK</i>		RPEQ: 1470	
REV. DATE REVISIONS REC. APPR.		CAD FILE: LA7900-48V01A.dwg	

Cardno
 Level 1, 5 Gardner Close, Milton 4064
 P.O. Box 306, Toowoomba 4005.
 Email: cardno@cardno.com.au
 Web: www.cardno.com.au
 ACN: 051 074 982

SHUTE HARBOUR MARINA DEVELOPMENT SHUTE HARBOUR MARINA MARINA DRAINAGE LAYOUT PLAN	DATE: 1-08-2008 DRAWING No: 7900/48/01-311 A	Rv.
---	---	-----